



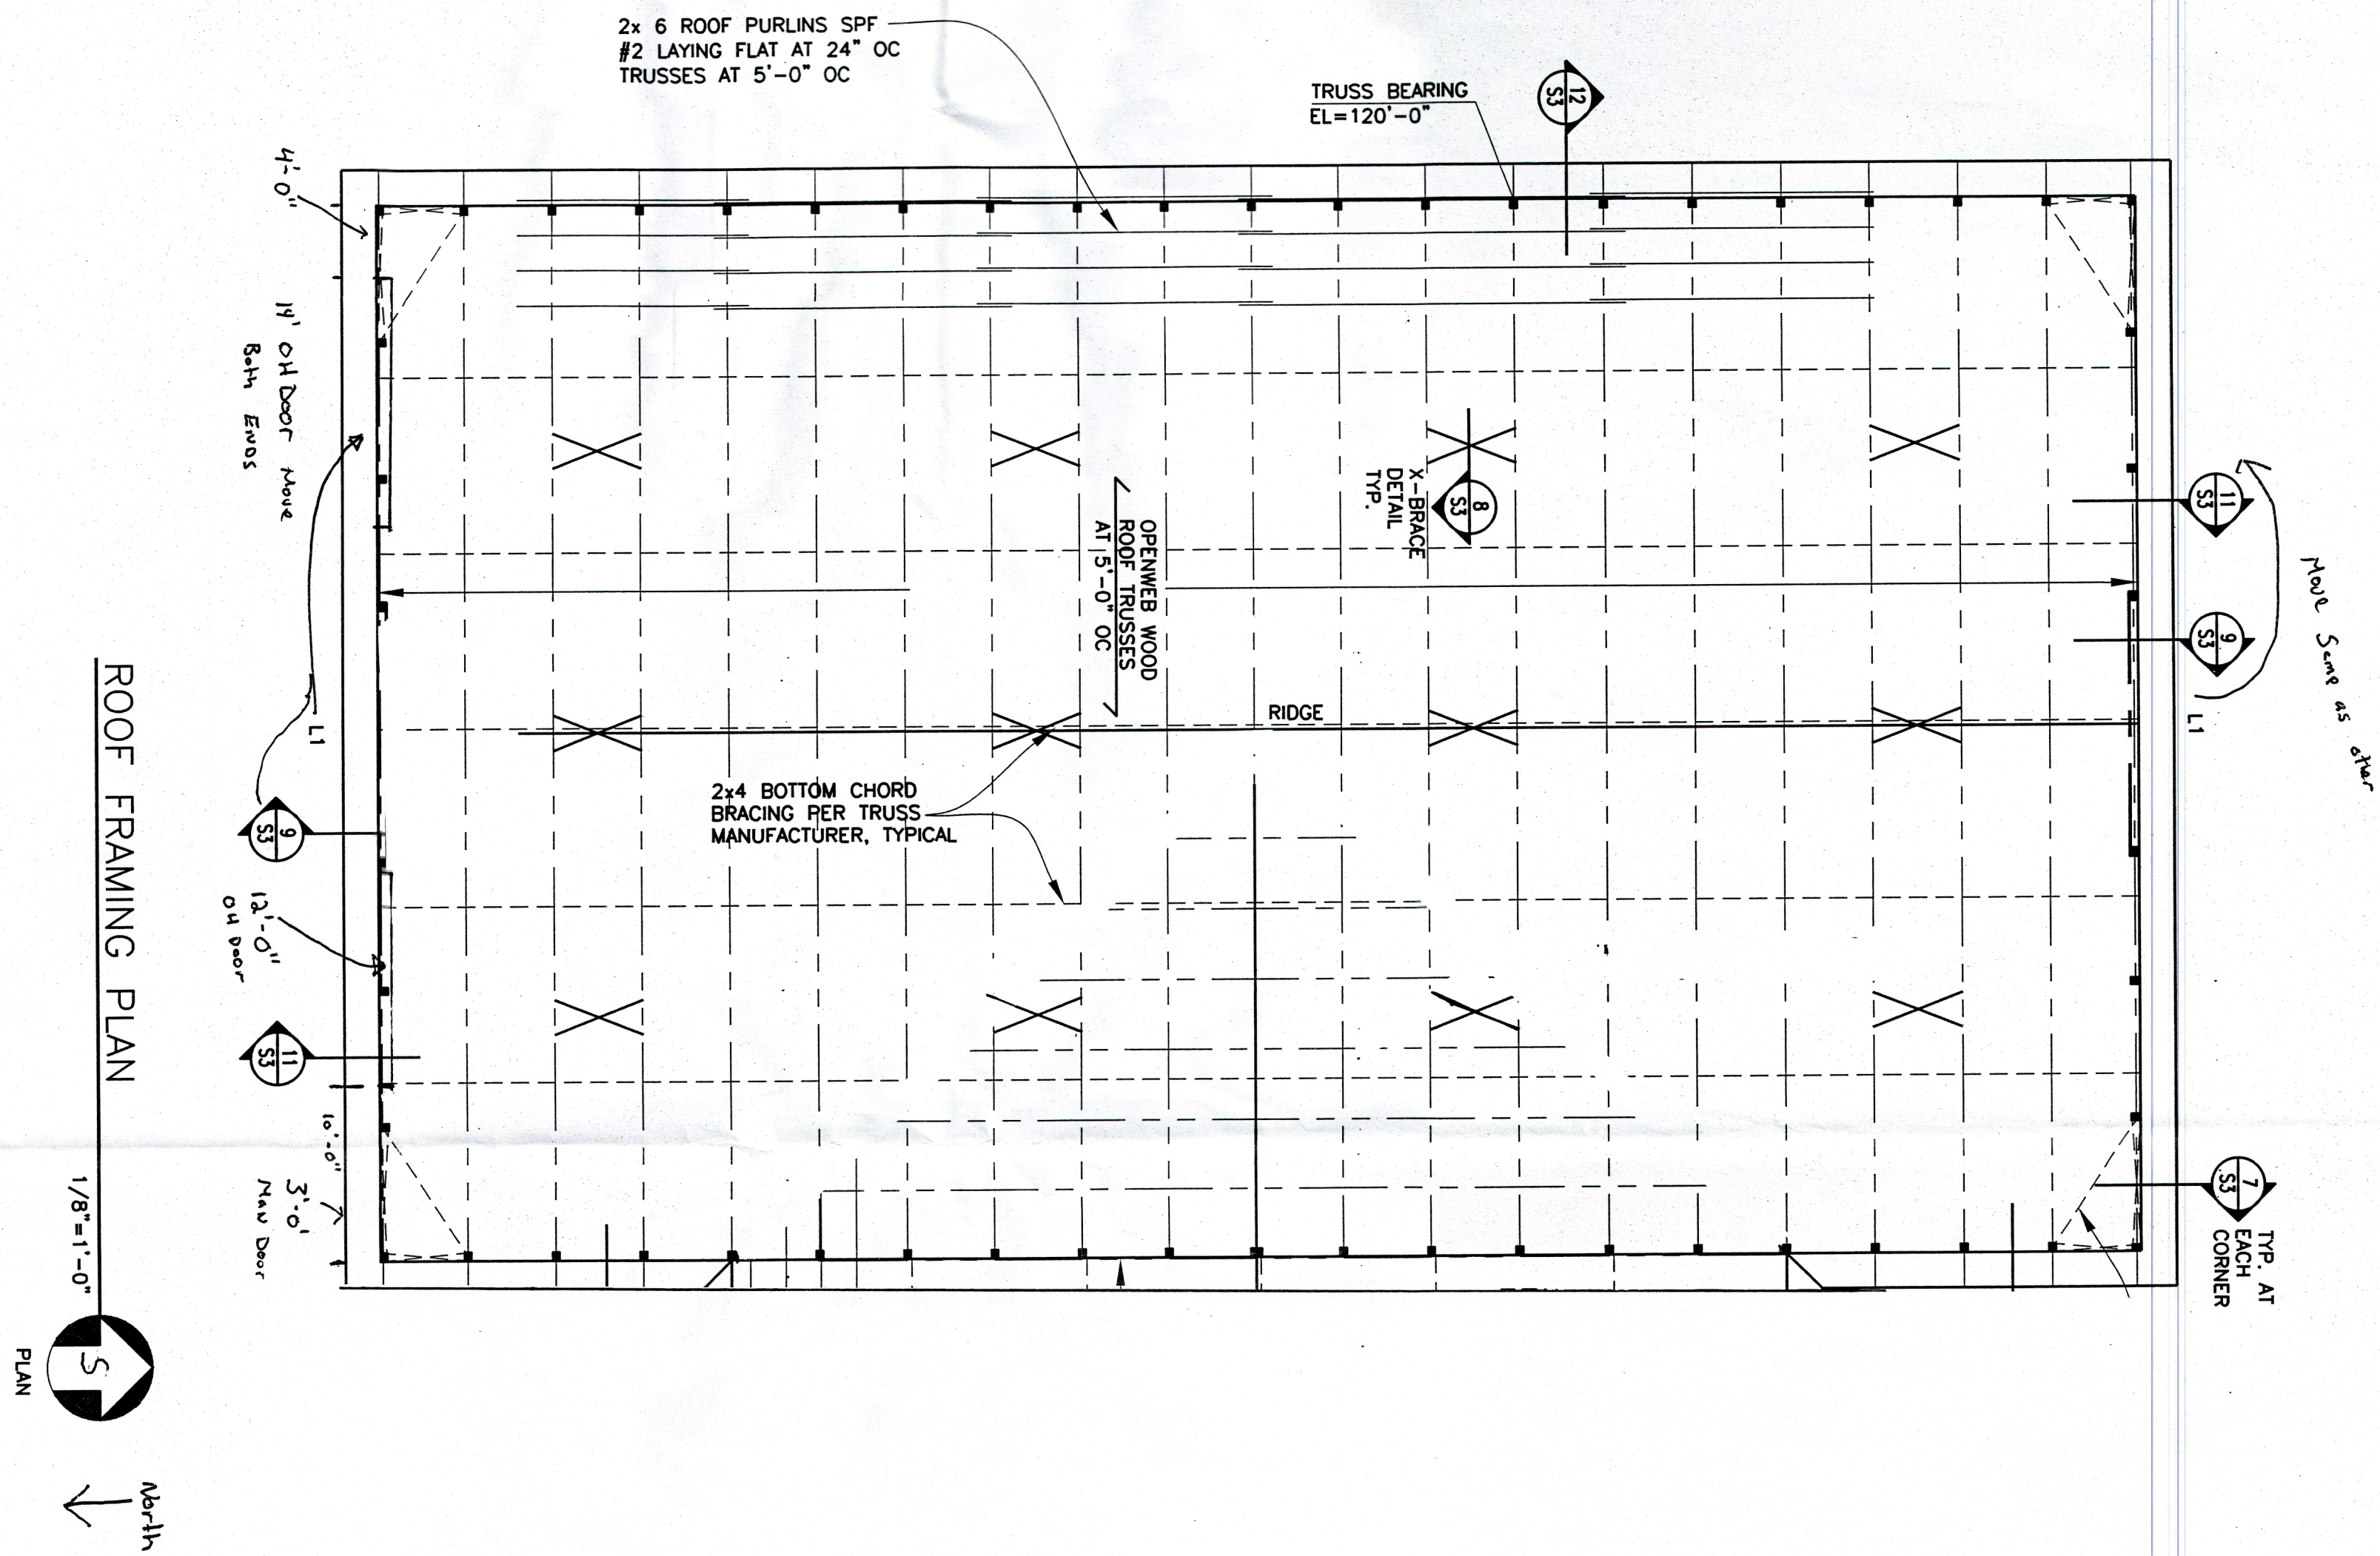

LINTEL SCHEDULE	
MARK	SIZE, TYPE
L1	(1) 1 1/2" x 1 1/2" LVL
L2	(1) 1 1/2" x 1 1/2" LVL CONT.

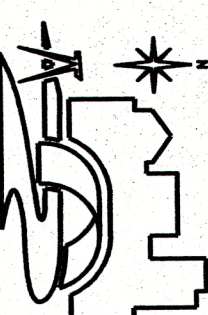

**DUFFY ENGINEERING
AND ASSOCIATES, INC.**
STRUCTURAL - CIVIL - MECHANICAL
350 Highway 10 South
Scott Cloud, MN 56304
Phone: (320) 259-6575
Fax: (320) 259-6991
Email: mduffy@duffyeng.com

I hereby certify that this plan, specification or report was prepared by me or under my direct supervision and that I am a duly Licensed Engineer in the State of Minnesota.

MINNESOTA
JOHN A. DUFFY, P.E.
08-11-17 49214
0016 License No.

REVISIONS:		
No.	Date	Action
1	5-9-2019	Removed 40'x60' Attached
2	5-9-2019	Moved 14'-0" OH Door Bath Ends to 4'-0" off East Side wall. Added 12'-0" OH Door on South End. + 3'-0" Man Door.

ROOF FRAMING PLAN

CITYVIEW ELECTRIC OFFICE
60'x100' & 40'x60' BLDG
14309 LAKE DRIVE NE
COLUMBUS, MN 55025

Project No.: 17542
Date: 08-11-17
Drawn by: GLW
Checked by: TMD